




PLUMBING FIXTURE SCHEDULE


MK	FIXTURE	MODEL NO. #	MATL.	ACCESS.	FU	TRAP	COLD	WARM	WASTE
WCH	WATER CLOSET	AMERICAN STANDARD CADET #28332	VITREOUS CHINA	CLEARITE OPEN FRONT SEAT #5	6	INTEGRAL	1/2"	-	3"
LUM	HANDICAP LAVATORY	AMERICAN STANDARD ROXALYN #019-073	VITREOUS CHINA	FAUCET #4362114 A-MARILIBHERITAGE	2	T123/018	1/2"	1/2"	1 1/2"
CO	CLEANOUT	ZURN Z-14600-6	CAST IRON	-	-	-	-	-	1 1/2"
EUC	ELECTRIC WATER COOLER	ELKAY E7L5C	-	-	-	INTEGRAL	1/2"	-	-

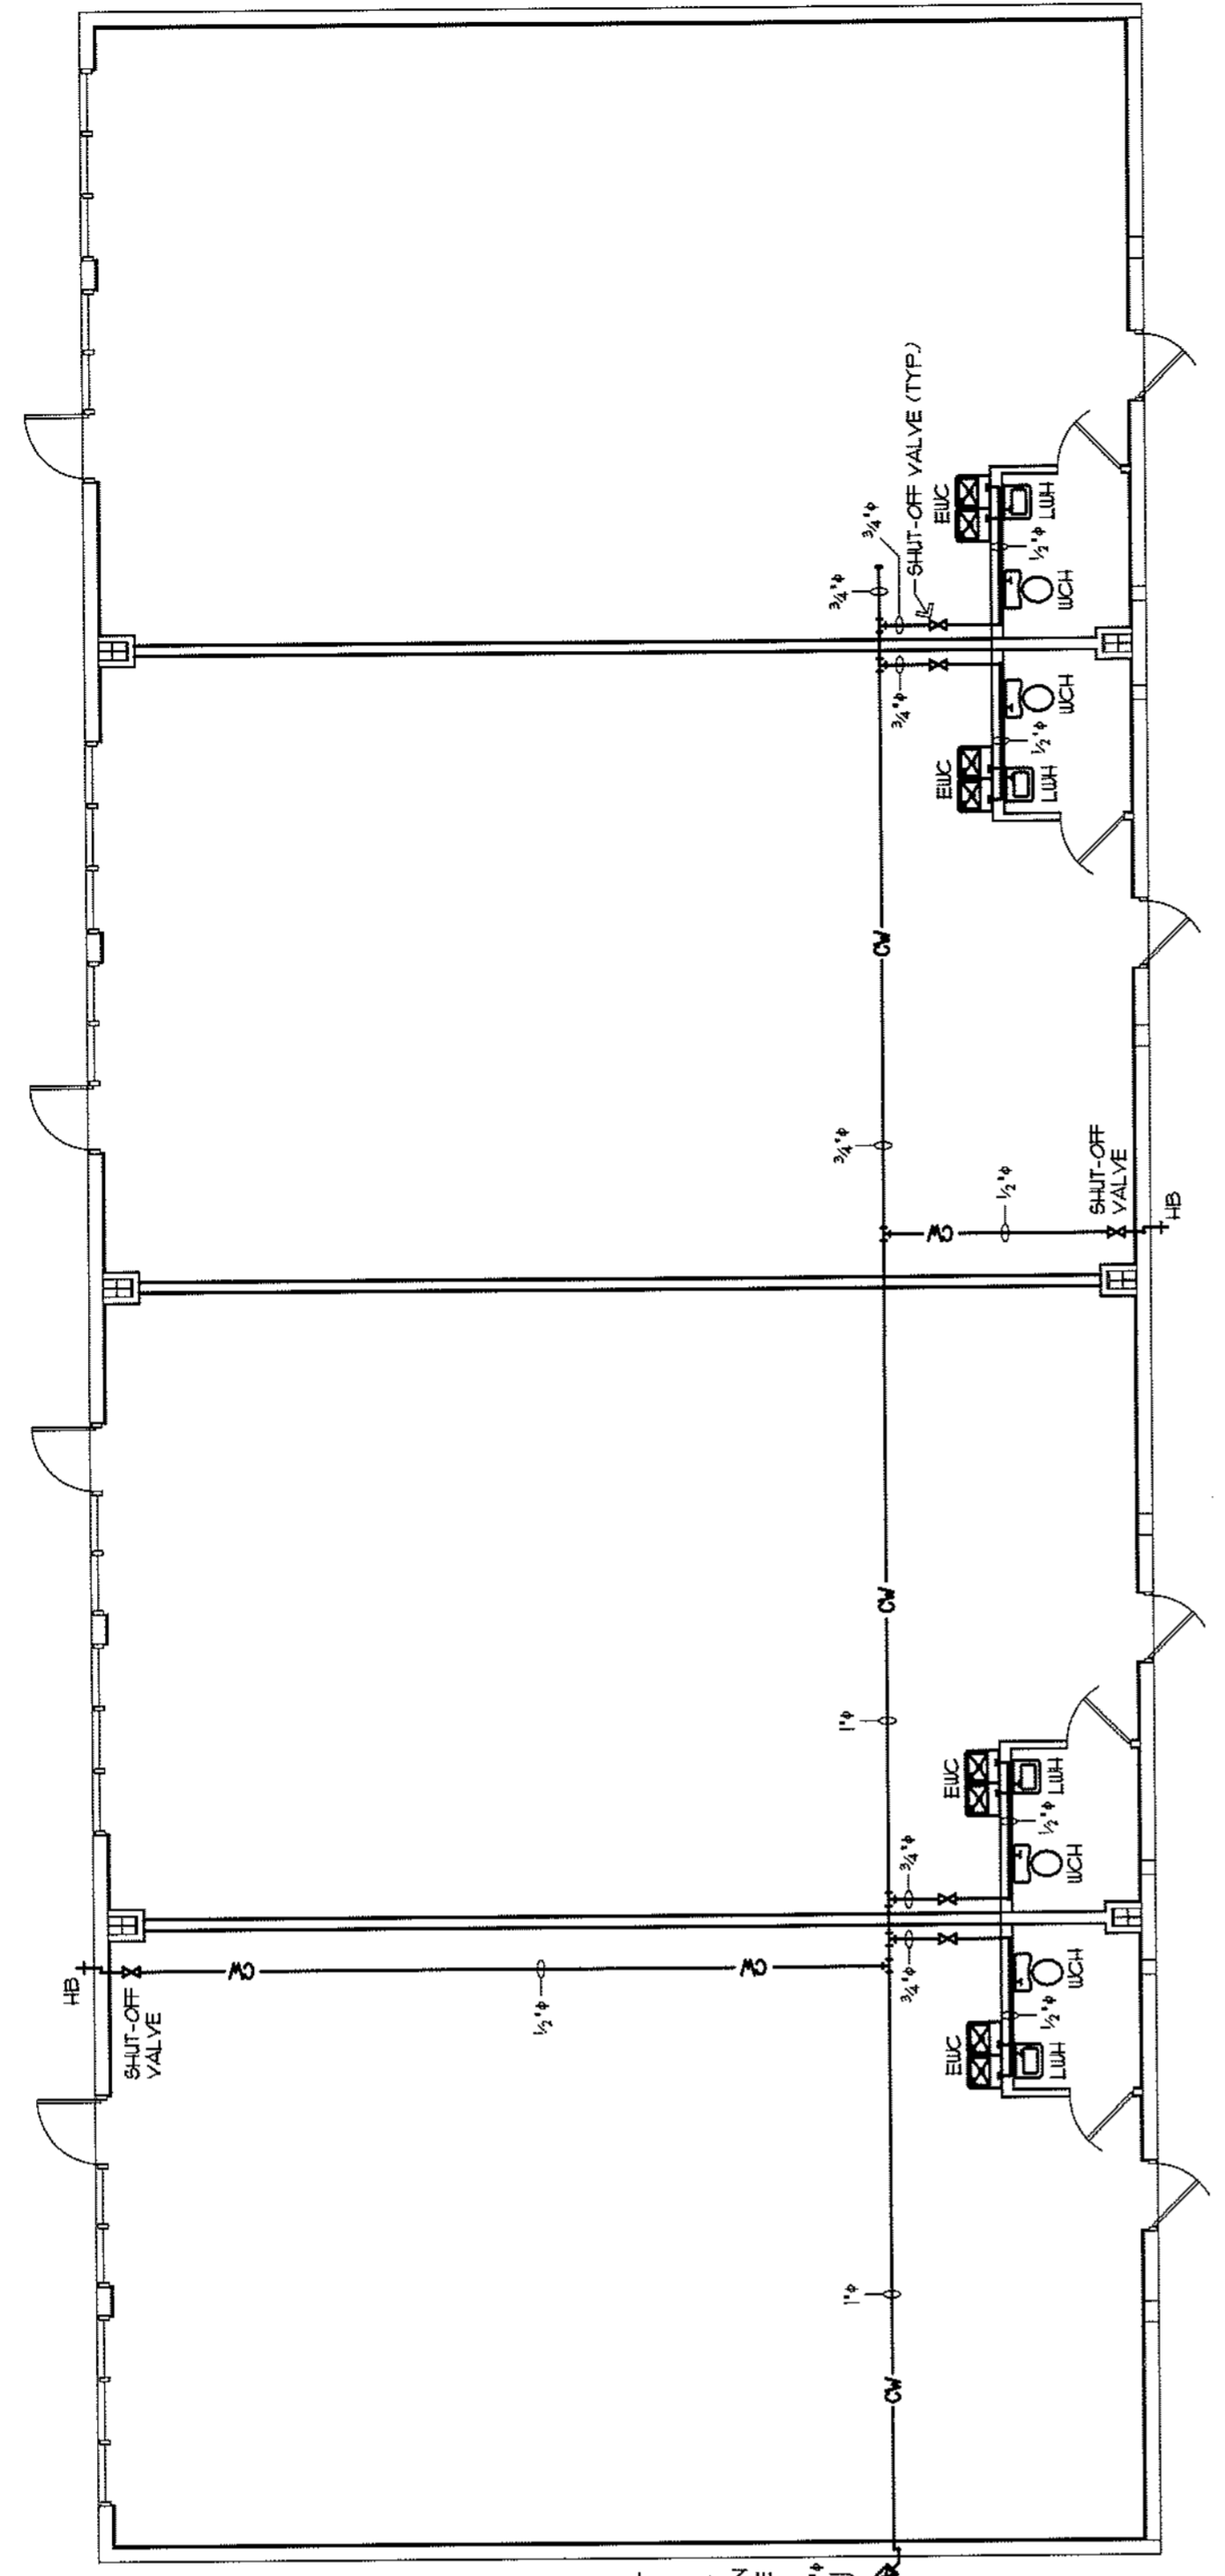


WATER SUPPLY PLAN
 SCALE: 1/8" = 1'-0"

PLUMBING LEGEND


SYMBOL	DESCRIPTION	MATERIAL
(Symbol)	SMOOTH BORE WASTE PIPING	PVC 1120
(Symbol)	SMOOTH BORE WASTE PIPING	PVC 1120
(Symbol)	COLD WATER PIPING, ROSE BENDING	PVC 1120
(Symbol)	COLD WATER PIPING, ROSE BENDING	PVC 1120
(Symbol)	CONCRETE DRAIN, 1/2" (1/2" HANDED) RELIEF	CONC
(Symbol)	CONCRETE DRAIN, 1/2" (1/2" HANDED) RELIEF	CONC
(Symbol)	LINE SIZE DATE VALVE	MS02 1-111
(Symbol)	DATE VALVE SET IN PVC SLICE	MS02 1-111

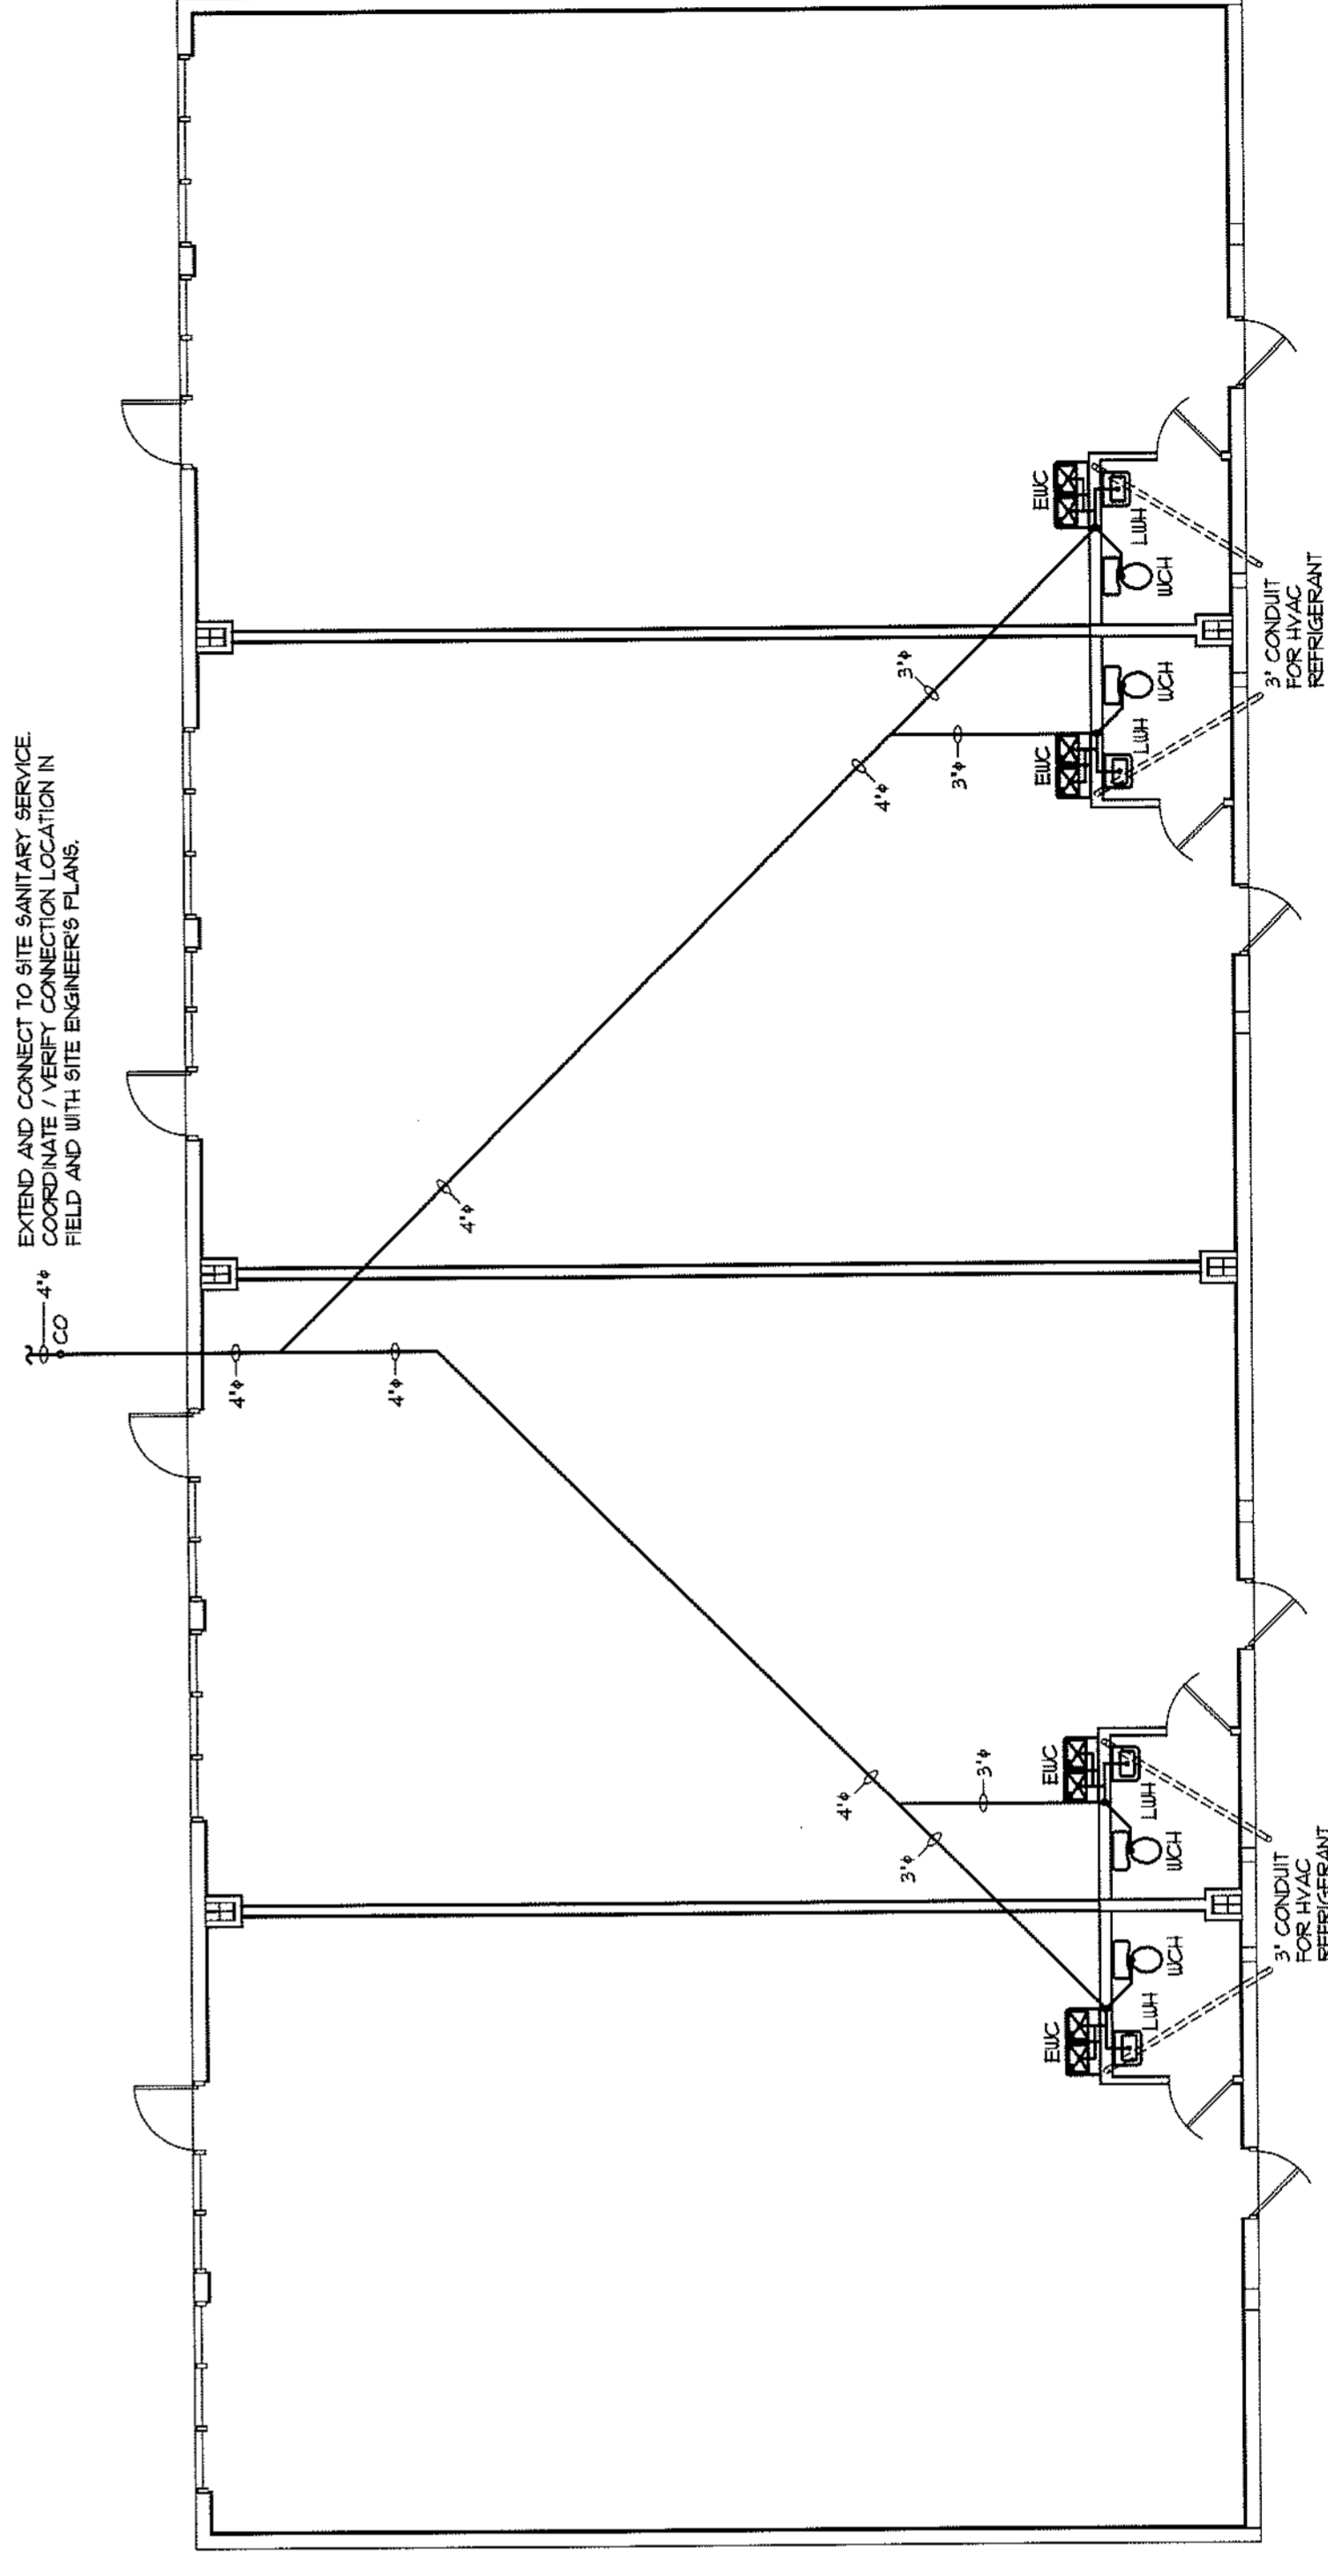


SANITARY PLAN
 SCALE: 1/8" = 1'-0"

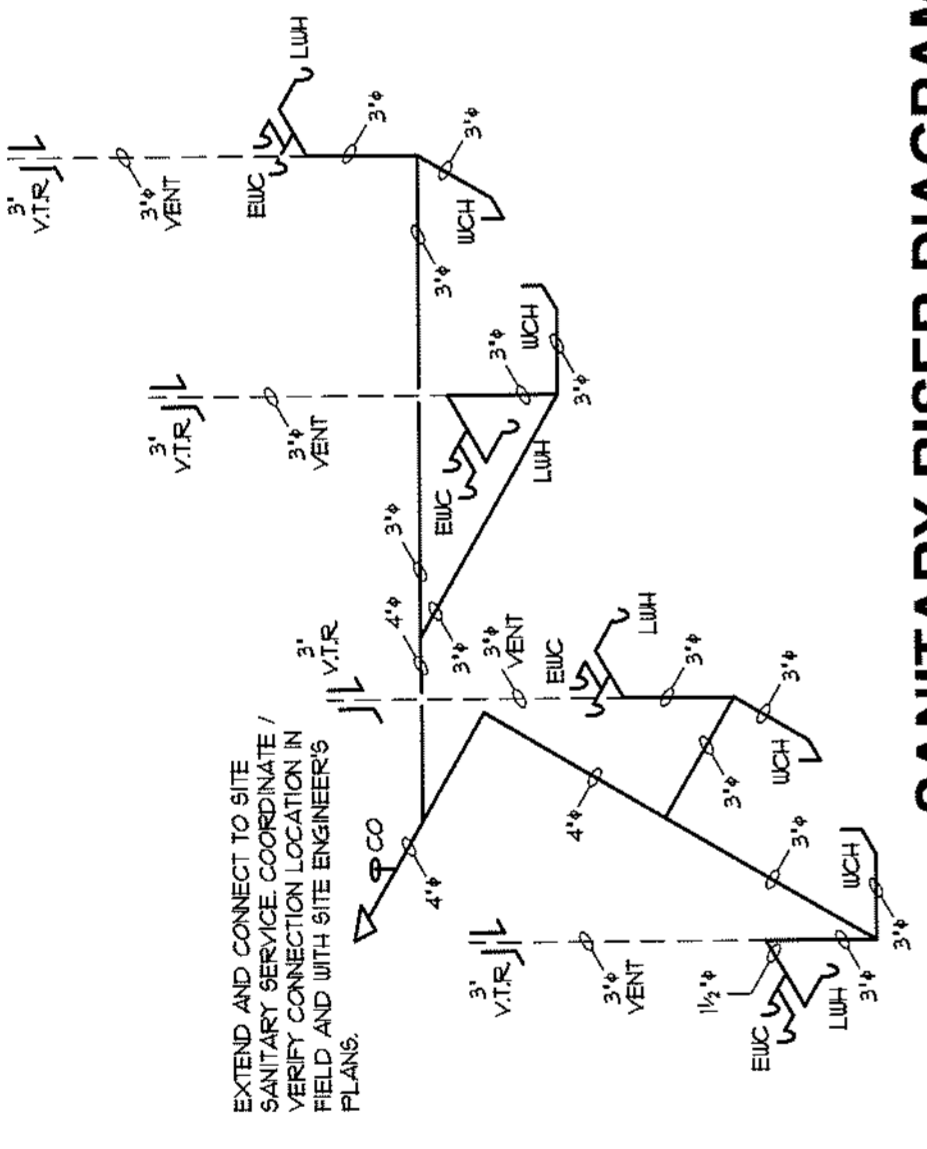

SANITARY RISER DIAGRAM
 NTS

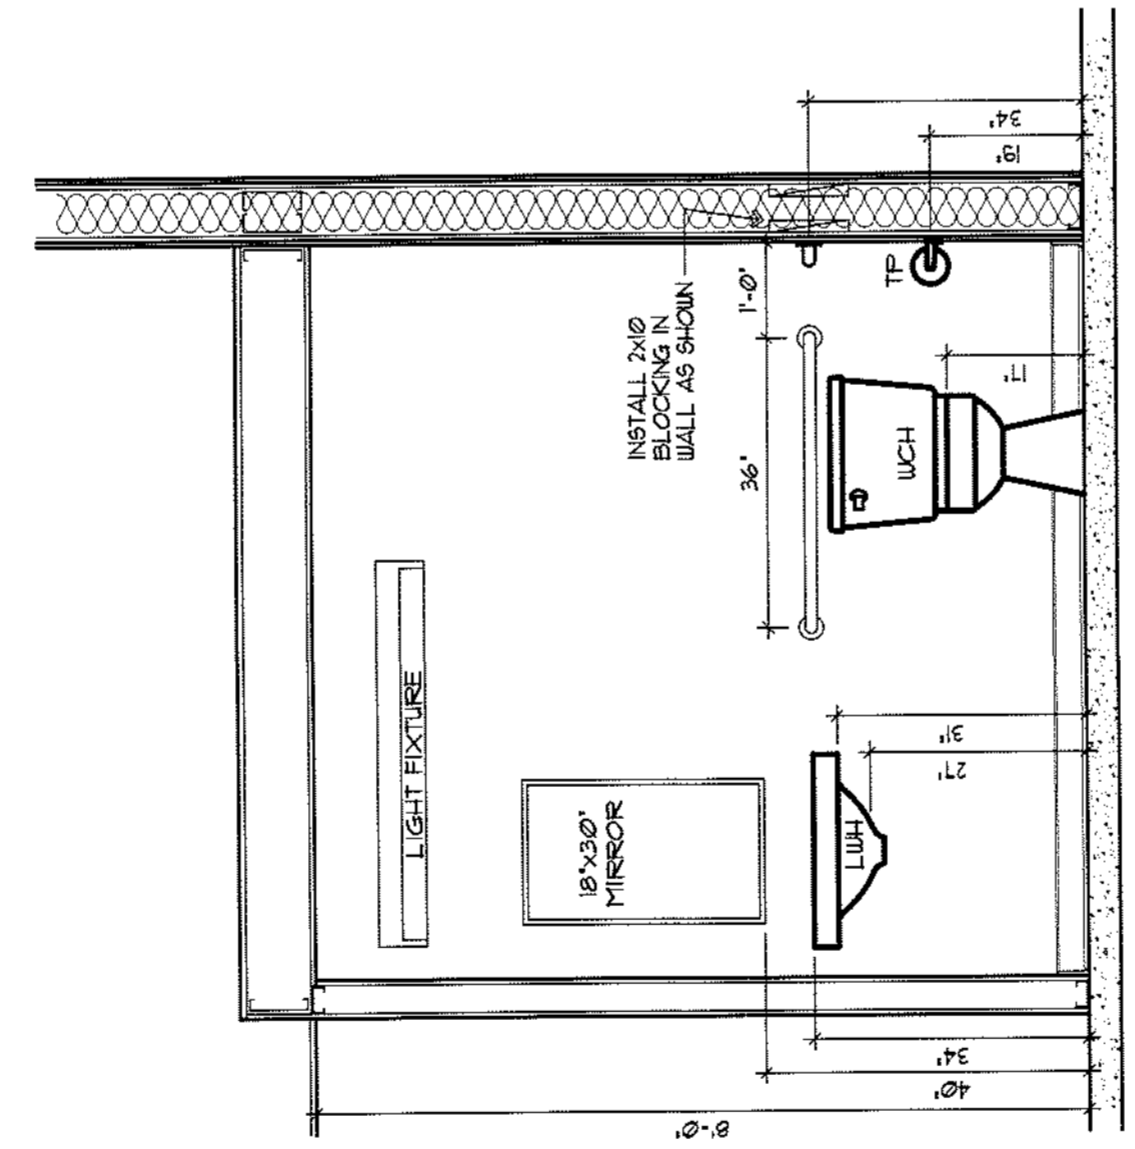


SECTION / ELEVATION
 SCALE: 1/2" = 1'-0"

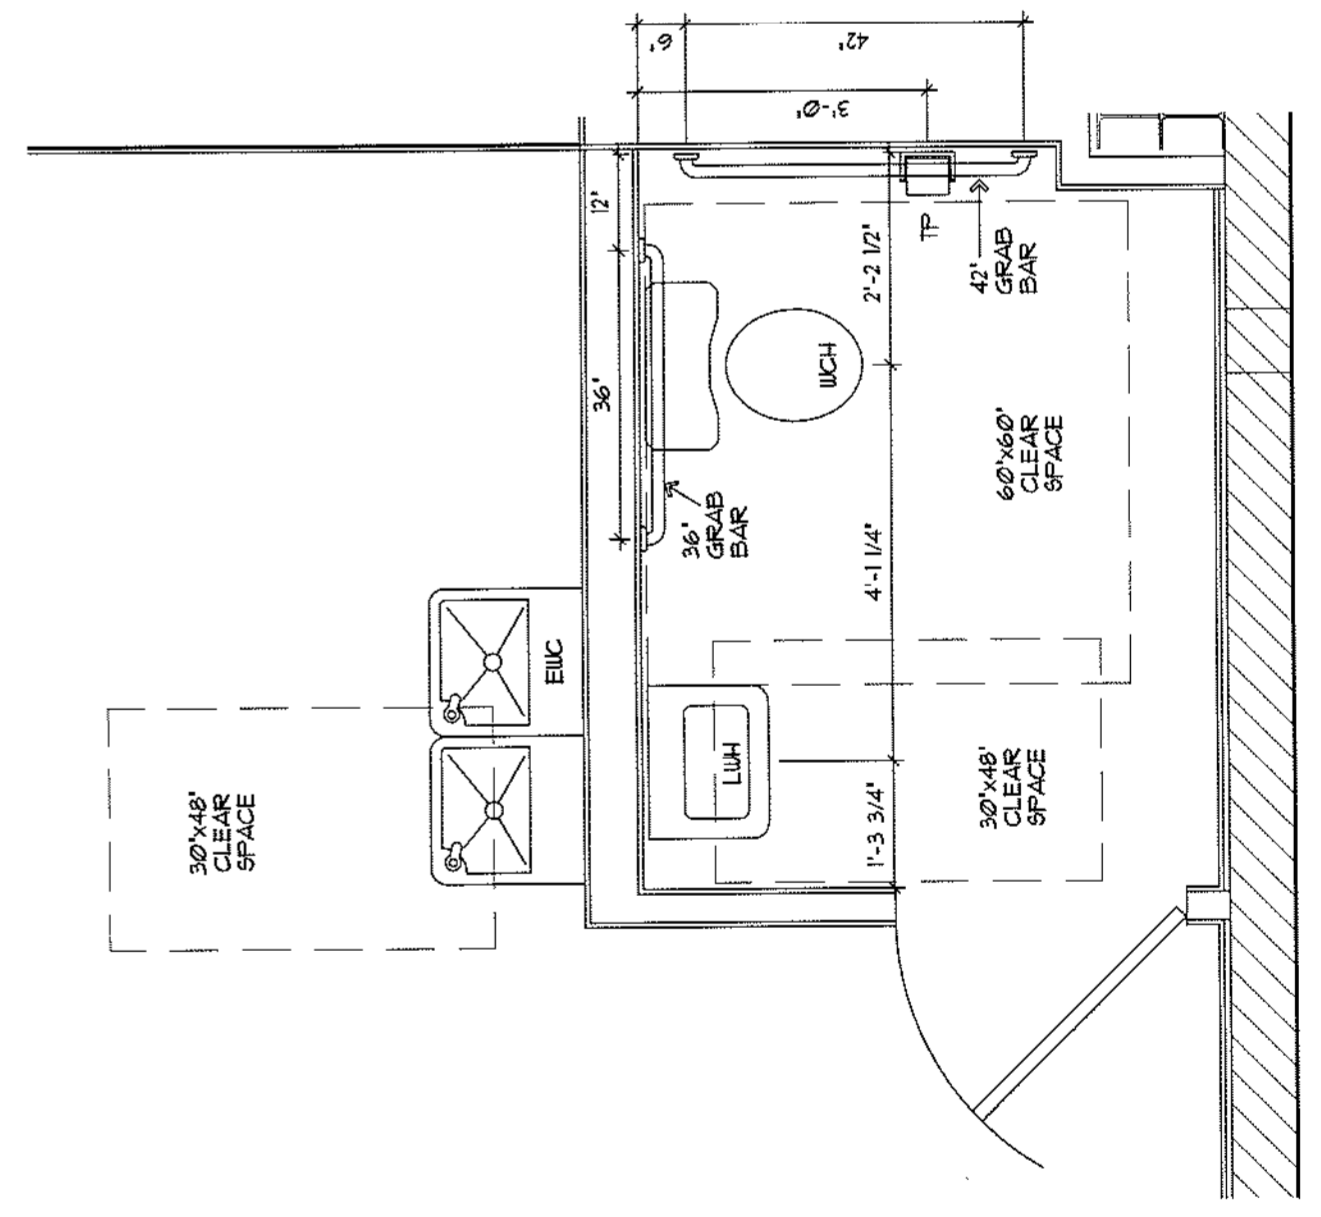

ENLARGED PLAN
 SCALE: 1/2" = 1'-0"

- PLUMBING NOTES:**
- ALL SANITARY 4" VENT PIPING SHALL BE SCHEDULE 40 PVC WITH GLEED FITTINGS.
 - ALL WATER PIPING ABOVE GRADE SHALL BE CPVC.
 - ALL EXPOSED PIPING SHALL BE CHROME PLATED AND EACH FIXTURE SHALL HAVE HOT AND COLD WATER SHUTOFF VALVES SERVING ONLY THAT FIXTURE.
 - ALL WORK SHALL BE PERFORMED AND COMPLETED IN STRICT ACCORDANCE WITH ALL LOCAL, STATE AND NATIONAL CODES.
 - DO NOT INSTALL ANY PIPING ABOVE ELECTRICAL PANELS.
 - IT IS THE PLUMBING CONTRACTORS RESPONSIBILITY FOR FINAL CONNECTION TO THE SITE UTILITIES.
 - FIELD VERIFY LOCATIONS AND INVERTS FOR ALL EXISTING OR PROPOSED SITE UTILITIES PRIOR TO INSTALLATION OF ANY NEW PIPING.
 - THERE SHALL BE NO DIRECT CONTACT BETWEEN COPPER AND MASONRY, CONCRETE OR METALLIC HANGERS AND OR SUPPORTS. INSULATE CONTACT WITH SOLID PVC INSULATION IN ALL INSTALLATIONS.
 - ALL UNDERGROUND PIPING TO BE INDEPENDENTLY SUPPORTED THROUGHOUT ITS ENTIRE LENGTH.
 - PROVIDE ALL ORBITS, FITTINGS, ETC. REQUIRED FOR THE PLUMBING SYSTEM. THE PLUMBING SYSTEM THE PLUMBING LAYOUT IS SCHEMATIC. ACTUAL LAYOUT OF PLUMBING PIPING MAY DIFFER FROM THAT INDICATED. ALL PIPING IS TO BE INSTALLED IN STRICT ACCORDANCE WITH ALL APPLICABLE CODES. THE PLUMBING CONTRACTOR SHALL COORDINATE WITH ALL OTHER TRADES FOR THE INSTALLATION LOCATIONS WITH ALL OTHER STRUCTURAL, MECHANICAL, ELECTRICAL, CIVIL, AND ARCHITECTURAL COMPONENTS PRIOR TO THE INSTALLATION OF ANY PLUMBING PIPING.

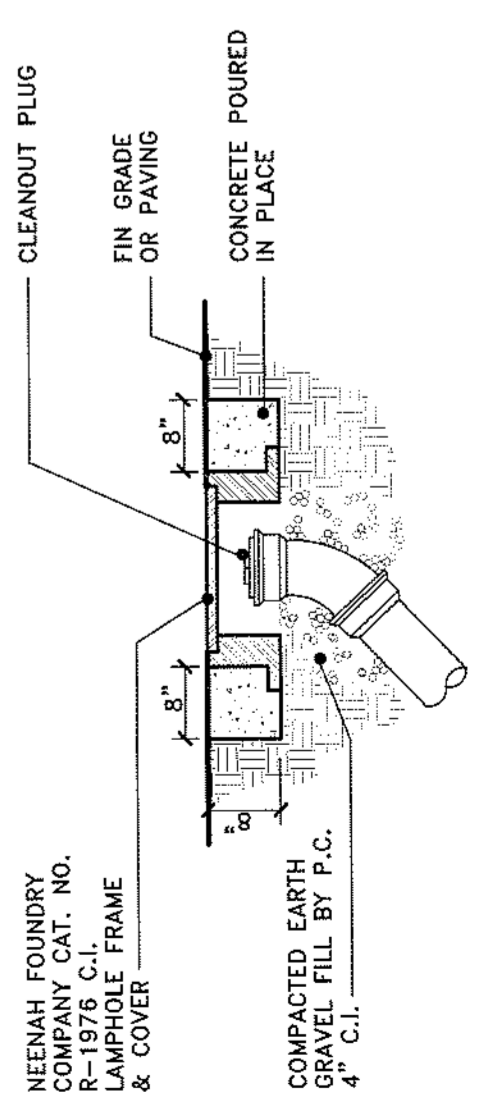

EXTERIOR CLEANOUT
 NOT TO SCALE